


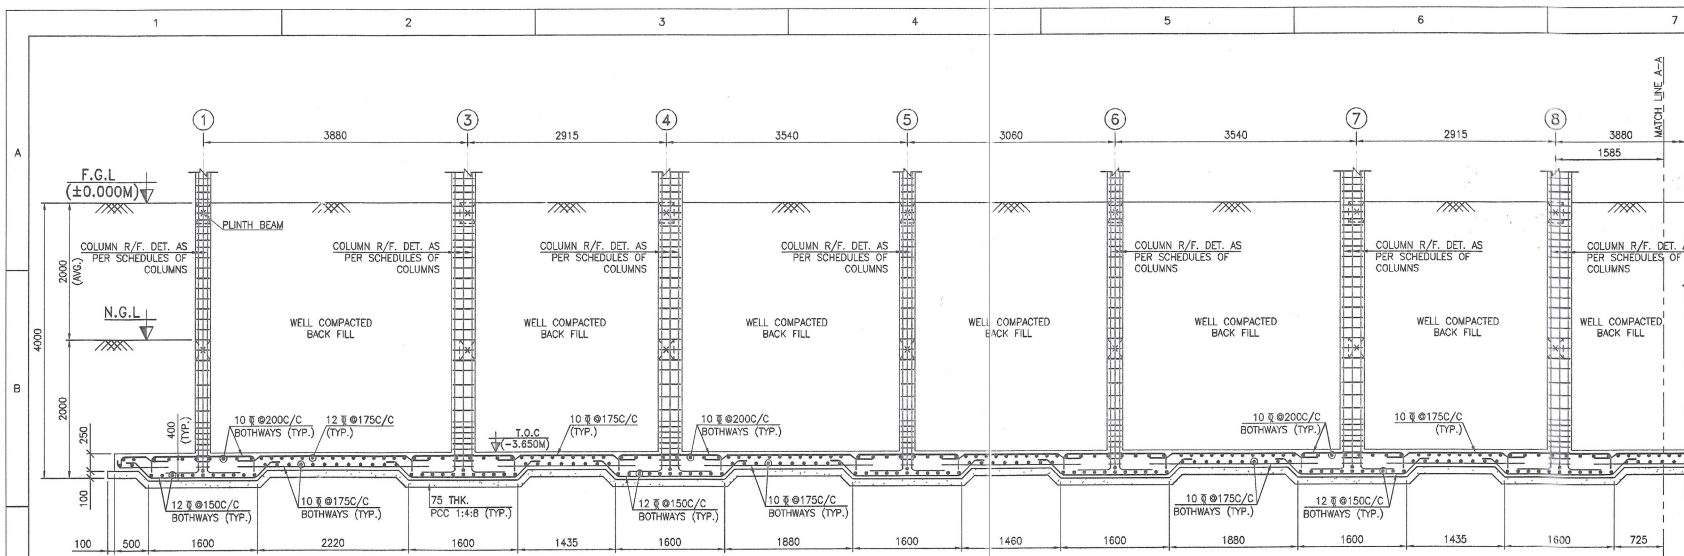


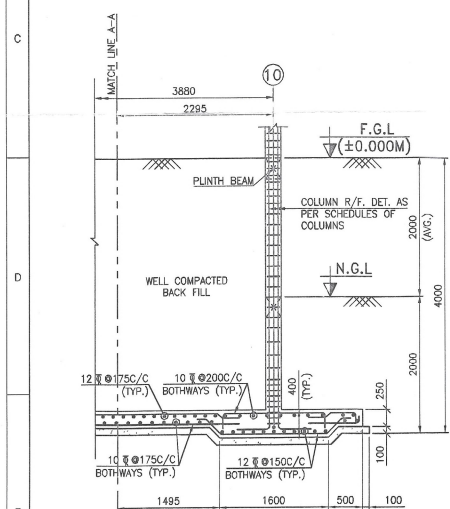

SECTION 1-1
(SCALE 1:50)

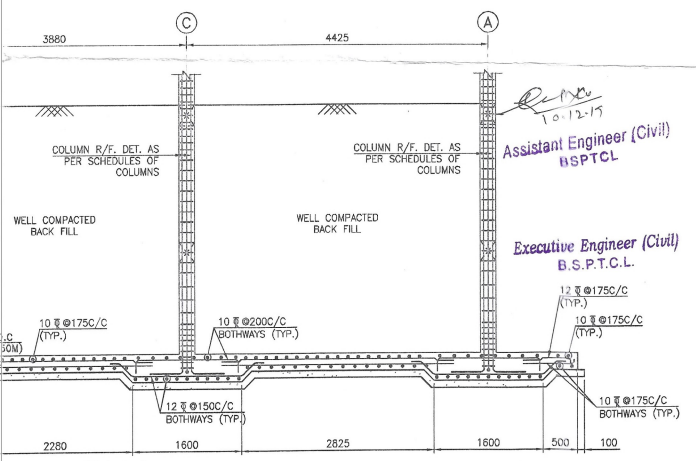


SECTION 1-1
(SCALE 1:50)

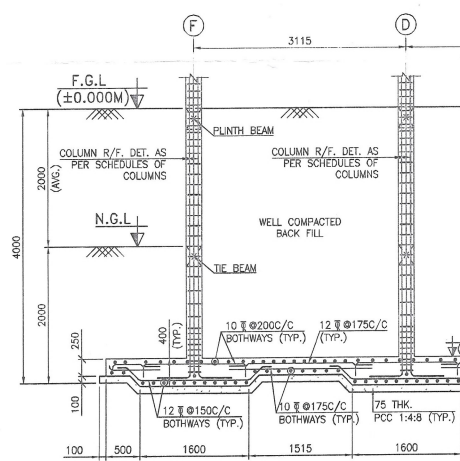

SECTION 2-2
(SCALE 1:50)

SCHEDULE OF COLUMN & REINF. DETAIL :-

COLUMN TYPE.	NO. OF COLUMNS	COLUMN SIZE	LONGITUDINAL REINFORCEMENT DETAILS	SPECIAL CONFINING TIES (S)	NORMAL TIES (N)	TIES AT LAPPING LOCATION (P)	COLUMN TERMINATION LEVEL (T.O.C)
C1	13	230 x 350	4-16 (a) + 2-12 (b)	8 (a) 100 C/C	8 (a) 190 C/C	8 (a) 150 C/C	+6.550M LVL
C1a	02	230 x 350	4-16 (a) + 2-12 (b)	8 (a) 100 C/C	8 (a) 190 C/C	8 (a) 150 C/C	+9.300M LVL
C2	07	230 x 350	8-16 (a)	8 (a) 100 C/C	8 (a) 190 C/C	8 (a) 150 C/C	+6.550M LVL
C2a	04	230 x 350	8-16 (a)	8 (a) 100 C/C	8 (a) 190 C/C	8 (a) 150 C/C	+9.300M LVL
C3	04	230 x 350	10-16 (a)	8 (a) 100 C/C	8 (a) 190 C/C	8 (a) 150 C/C	+6.550M LVL
C4	04	230 x 400	10-16 (a) + 2-12 (b)	8 (a) 100 C/C	8 (a) 190 C/C	8 (a) 150 C/C	+6.550M LVL
TOTAL	34						

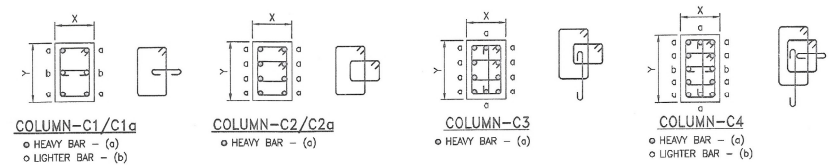

- NOTE**
- ALL DIMENSIONS ARE IN MILLIMETERS, LEVELS AND CO-ORDINATES ARE IN METERS.
 - FOR ALL OTHER NOTES AND LEGENDS PLEASE REFER THIS DRAWING 01 OF 02.

- REFERENCE DRAWINGS**
- KEC-SB937-GRL-01-1001 - OVERALL GENERAL ARRANGEMENT LAYOUT PLAN.
 - KEC-SB937-GRL-90-0002 - OVERALL FOUNDATION LAYOUT.
 - KEC-SB937-GRL-93-3001 - 3BHK APARTMENT ARCHITECTURAL LAYOUT.
- Drawing is approved**
subject to overall responsibility of the contractor in terms of contract agreement.
- Assistant Engineer (Civil)**
HSPTCL
- Executive Engineer (Civil)**
B.S.P.T.C.L.
- Superintending Engineer (Civil)**
BSPTCL
- Chief Engineer (Civil)**
BSPTCL

Bihar State Power Transmission Company Limited (BSPTCL)

Title: FOUNDATION LAYOUT & COLUMN DETAIL FOR 3BHK APARTMENT

Drg.No.:- CD_3BHK21-10

Scale: 1:100

Sheet: 02 of 02