

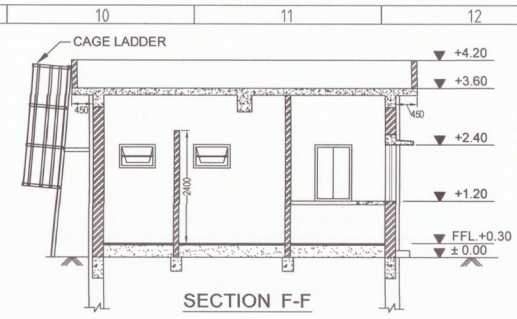
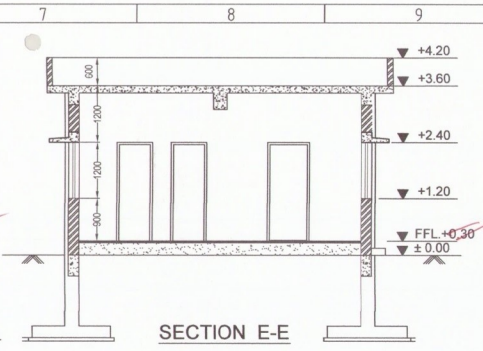
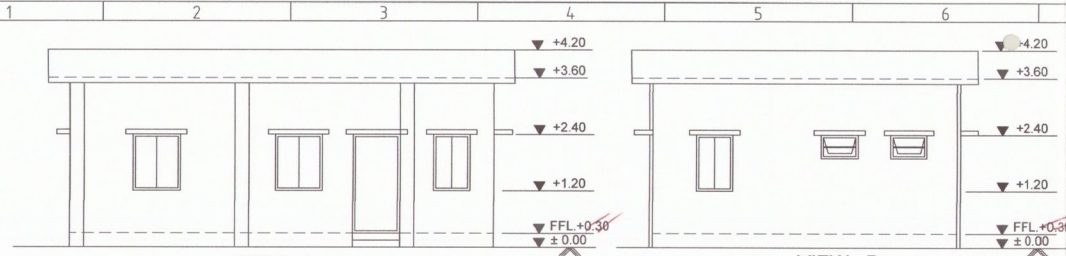
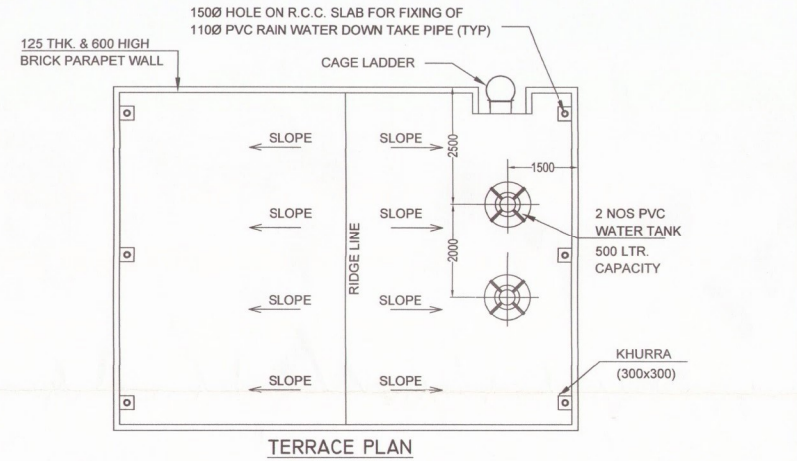
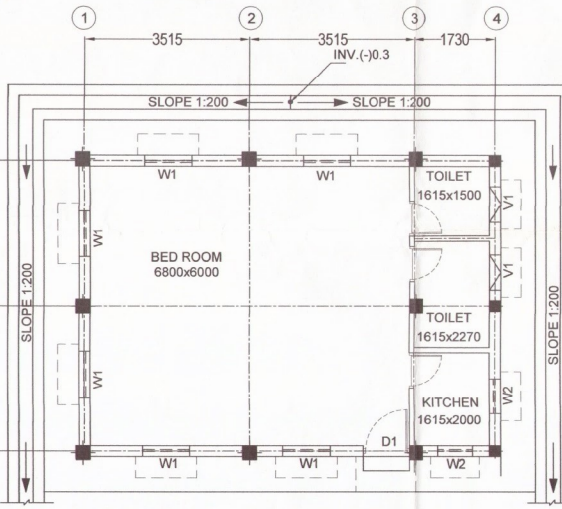


the levels may be adjusted accordingly
+600mm
+600mm

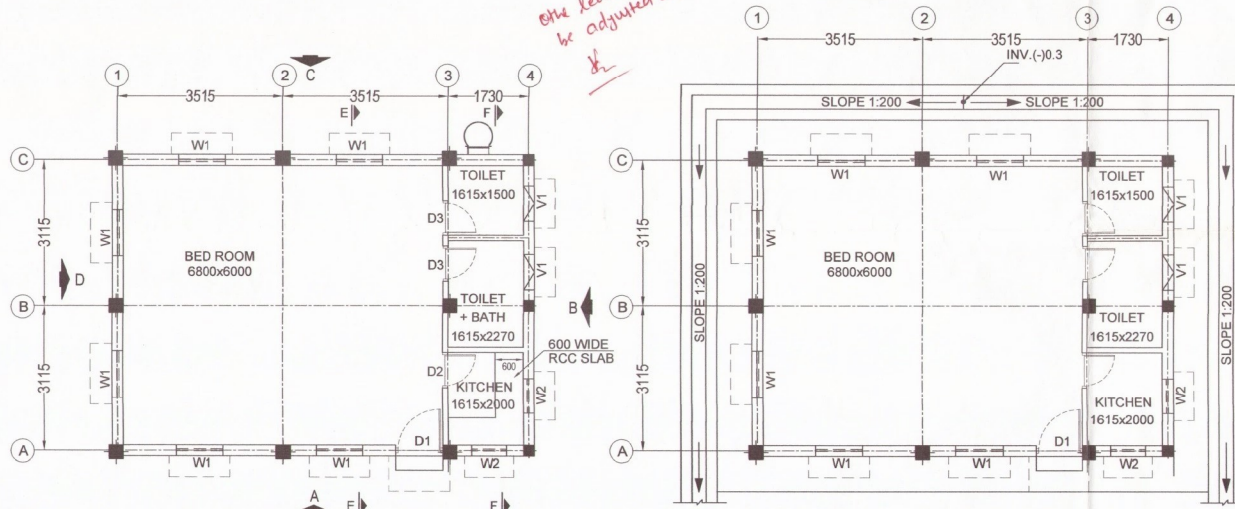

SL. NO.	MARKED	NO.	OPEN SIZE		SILL LEVEL (FROM FL.)	LINTEL LEVEL (FROM FL.)	DESCRIPTION
			WIDTH	HEIGHT			
1	D1	1	1000	2100	0.00	2.10	SINGLE LEAF WOODEN DOOR WITH 2 COATS OF SYNTHETIC ENAMEL PAINT OVER A COAT OF PRIMER
2	D2	1	900	2100	0.00	2.10	SINGLE LEAF WOODEN DOOR WITH 2 COATS OF SYNTHETIC ENAMEL PAINT OVER A COAT OF PRIMER
3	D3	2	750	2100	0.00	2.10	SINGLE LEAF WOODEN DOOR WITH 2 COATS OF SYNTHETIC ENAMEL PAINT OVER A COAT OF PRIMER
4	W1	6	1000	1200	0.90	2.10	MS GLAZED OPENABLE WINDOW
5	W2	3	750	1200	0.90	2.10	MS GLAZED OPENABLE WINDOW
6	V1	2	750	600	1500	2.10	MS GLAZED TOP HUNG VENTILATOR

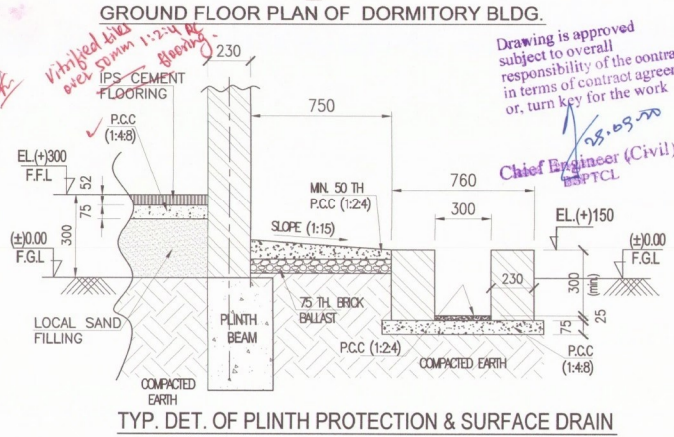

ROOF TREATMENT:-
 1. ROOF TREATMENT AS PER DSR ITEM NO. 22.7 WITH BROKEN BRICK BATS. FINISHING WITH JOINTLESS CEMENT MORTAR.

FINISHING SCHEDULE:-
 1. 12MM THICK CEMENT PLASTER OF MIX (1:6) SHALL BE PROVIDED ON INSIDE FACE OF THE WALL.
 2. 15MM THICK CEMENT PLASTER OF MIX (1:4) SHALL BE PROVIDED ON OUTSIDE FACE OF THE WALL.
 3. 6MM THICK CEMENT PLASTER OF MIX (1:4) SHALL BE PROVIDED ON CEILING.

NOTES
 1. (+) 0.00 SHALL BE READ AS F.G.L. OF SWITCH YARD.
 2. ALL DIMENSIONS ARE IN MM. & LEVELS IN METER.
 3. FINISHED FLOOR LEVEL OF ROOM IS EL. (+)0.3M ABOVE FINISHED GROUND LEVEL.
 4. TOP OF ROOF IS AT EL. (+)3.60M ABOVE FINISHED GROUND LEVEL.
 5. ALL FINISH DETAILS SHALL CONFORM TO TECHNICAL SPECIFICATION.
 6. ALL OUTSIDE WALL SHALL BE 230MM THK. & ALL INTERNAL PARTITION WALL SHALL BE 115 MM THK.

ENG. REF. DRG.:
 1. ELECTRICAL LAYOUT DRG. NO.: 0741NA-ASTN-SWYD-E-DRG-42-001

BIHAR STATE POWER TRANSMISSION COMPANY LIMITED(BSPTCL)

Title: GA DRAWING OF DORMITORY BUILDING

Drg. No.:- CD_DORITORY_18-01

Scale : N.T.S **Sheet : 01 OF 03**